


LUMINAIRE SCHEDULE									
Symbol	Label	Qty	Catalog Number	Description	Lamp	File	Lumens	LLF	Watts
	A	11	Spring City "Clearwater" 60 watt LED	CLW-LE100-X2-45-CR3-YSDP	LED 1W Cool White (350mA) (core only)	CLW-LE100-X2-45-CR3-YSDP.ies	Absolute	0.49	101.997
	B	11	LeoTek "Wall Sconce" 36 watt LED	CAST ALUMINUM HEATSINK HOUSING, CLEAR PLASTIC ENCLOSURE.	(36) WHITE LEDS WITH CLEAR PLASTIC OPTICS BELOW	LWS1-036-MV-CW-3M-XX_LTL_16606_10-06-2009.IES	Absolute	0.81	36.6

STATISTICS						
Description	Symbol	Avg	Max	Min	Max/Min	Avg/Min
Area Behind Building A	+	1.6 fc	3.5 fc	0.2 fc	17.5:1	8.0:1
Area Behind Building B	+	1.1 fc	3.5 fc	0.2 fc	17.5:1	5.5:1
Dumpster Area	+	1.1 fc	1.8 fc	0.4 fc	4.5:1	2.8:1
Site Lighting	+	2.1 fc	4.7 fc	0.2 fc	23.5:1	10.5:1

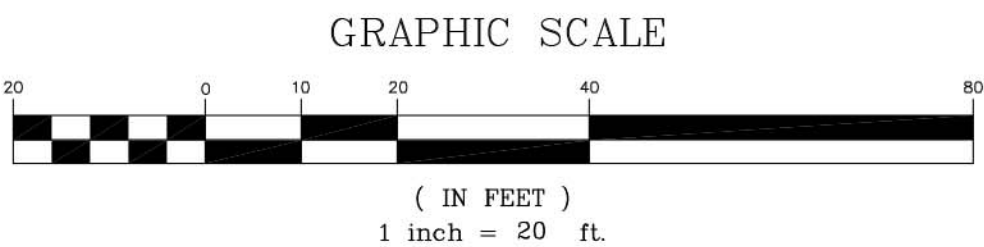

R: \PROJECTS\1925-01\CIVIL\DRAWINGS\CURRENT\C-1925-01\_L-1\_LIGHTING.DWG



23 High Street  
Portsmouth, NH 03801  
P: 603.431.8701  
F: 603.422.8707

FINAL APPROVAL BY DURHAM PLANNING BOARD.  
CERTIFIED BY MICHAEL BEHRENDT, TOWN PLANNER.

MICHAEL BEHRENDT      DATE



REV	DATE	DESCRIPTION
-----	------	-------------

APPLICANT/OWNER:  
ORION UNH LLC  
225 FRANKLIN STREET, 26TH FLOOR  
BOSTON, MA 02110

PROJECT:  
ORION  
STUDENT HOUSING  
25/35 MAIN STREET  
DURHAM, NEW HAMPSHIRE

PROJECT NO. 1925-01      DATE: 03-12-14

SCALE: 1" = 20'      DWG. NAME: LIGHTING

DRAFTED BY: PB      CHECKED BY: RPC

PREPARED BY:



**ALLEN & MAJOR ASSOCIATES, INC.**  
civil & structural engineering • land surveying  
environmental consulting • landscape architecture  
www.allenmajor.com  
250 COMMERCIAL STREET  
SUITE 1001  
MANCHESTER, NH 03101  
TEL: (603) 627-5500  
FAX: (603) 627-5501  
WOBURN, MA • LAKEVILLE, MA • MANCHESTER, NH

THIS DRAWING HAS BEEN PREPARED IN ELECTRONIC FORMAT.  
CLIENT/CLIENT'S REPRESENTATIVE OR CONSULTANT MAY BE PROVIDED COPIES OF DRAWINGS AND SPECIFICATIONS ON MAGNETIC MEDIA FOR HIS/HER INFORMATION AND USE FOR SPECIFIC APPLICATION TO THIS PROJECT. DUE TO THE POTENTIAL THAT THE MAGNETIC INFORMATION MAY BE MODIFIED UNINTENTIONALLY OR OTHERWISE, ALLEN & MAJOR ASSOCIATES, INC. MAY REMOVE ALL INDICATION OF THE DOCUMENT'S AUTHORSHIP ON THE MAGNETIC MEDIA. PRINTED REPRESENTATIONS OF THE DRAWINGS AND SPECIFICATIONS ISSUED SHALL BE THE ONLY RECORD COPIES OF ALLEN & MAJOR ASSOCIATES, INC.'S WORK PRODUCT.

DRAWING TITLE:      SHEET No.

LIGHTING PLAN      L-1

Copyright © 2013 Allen & Major Associates, Inc.  
All Rights Reserved