


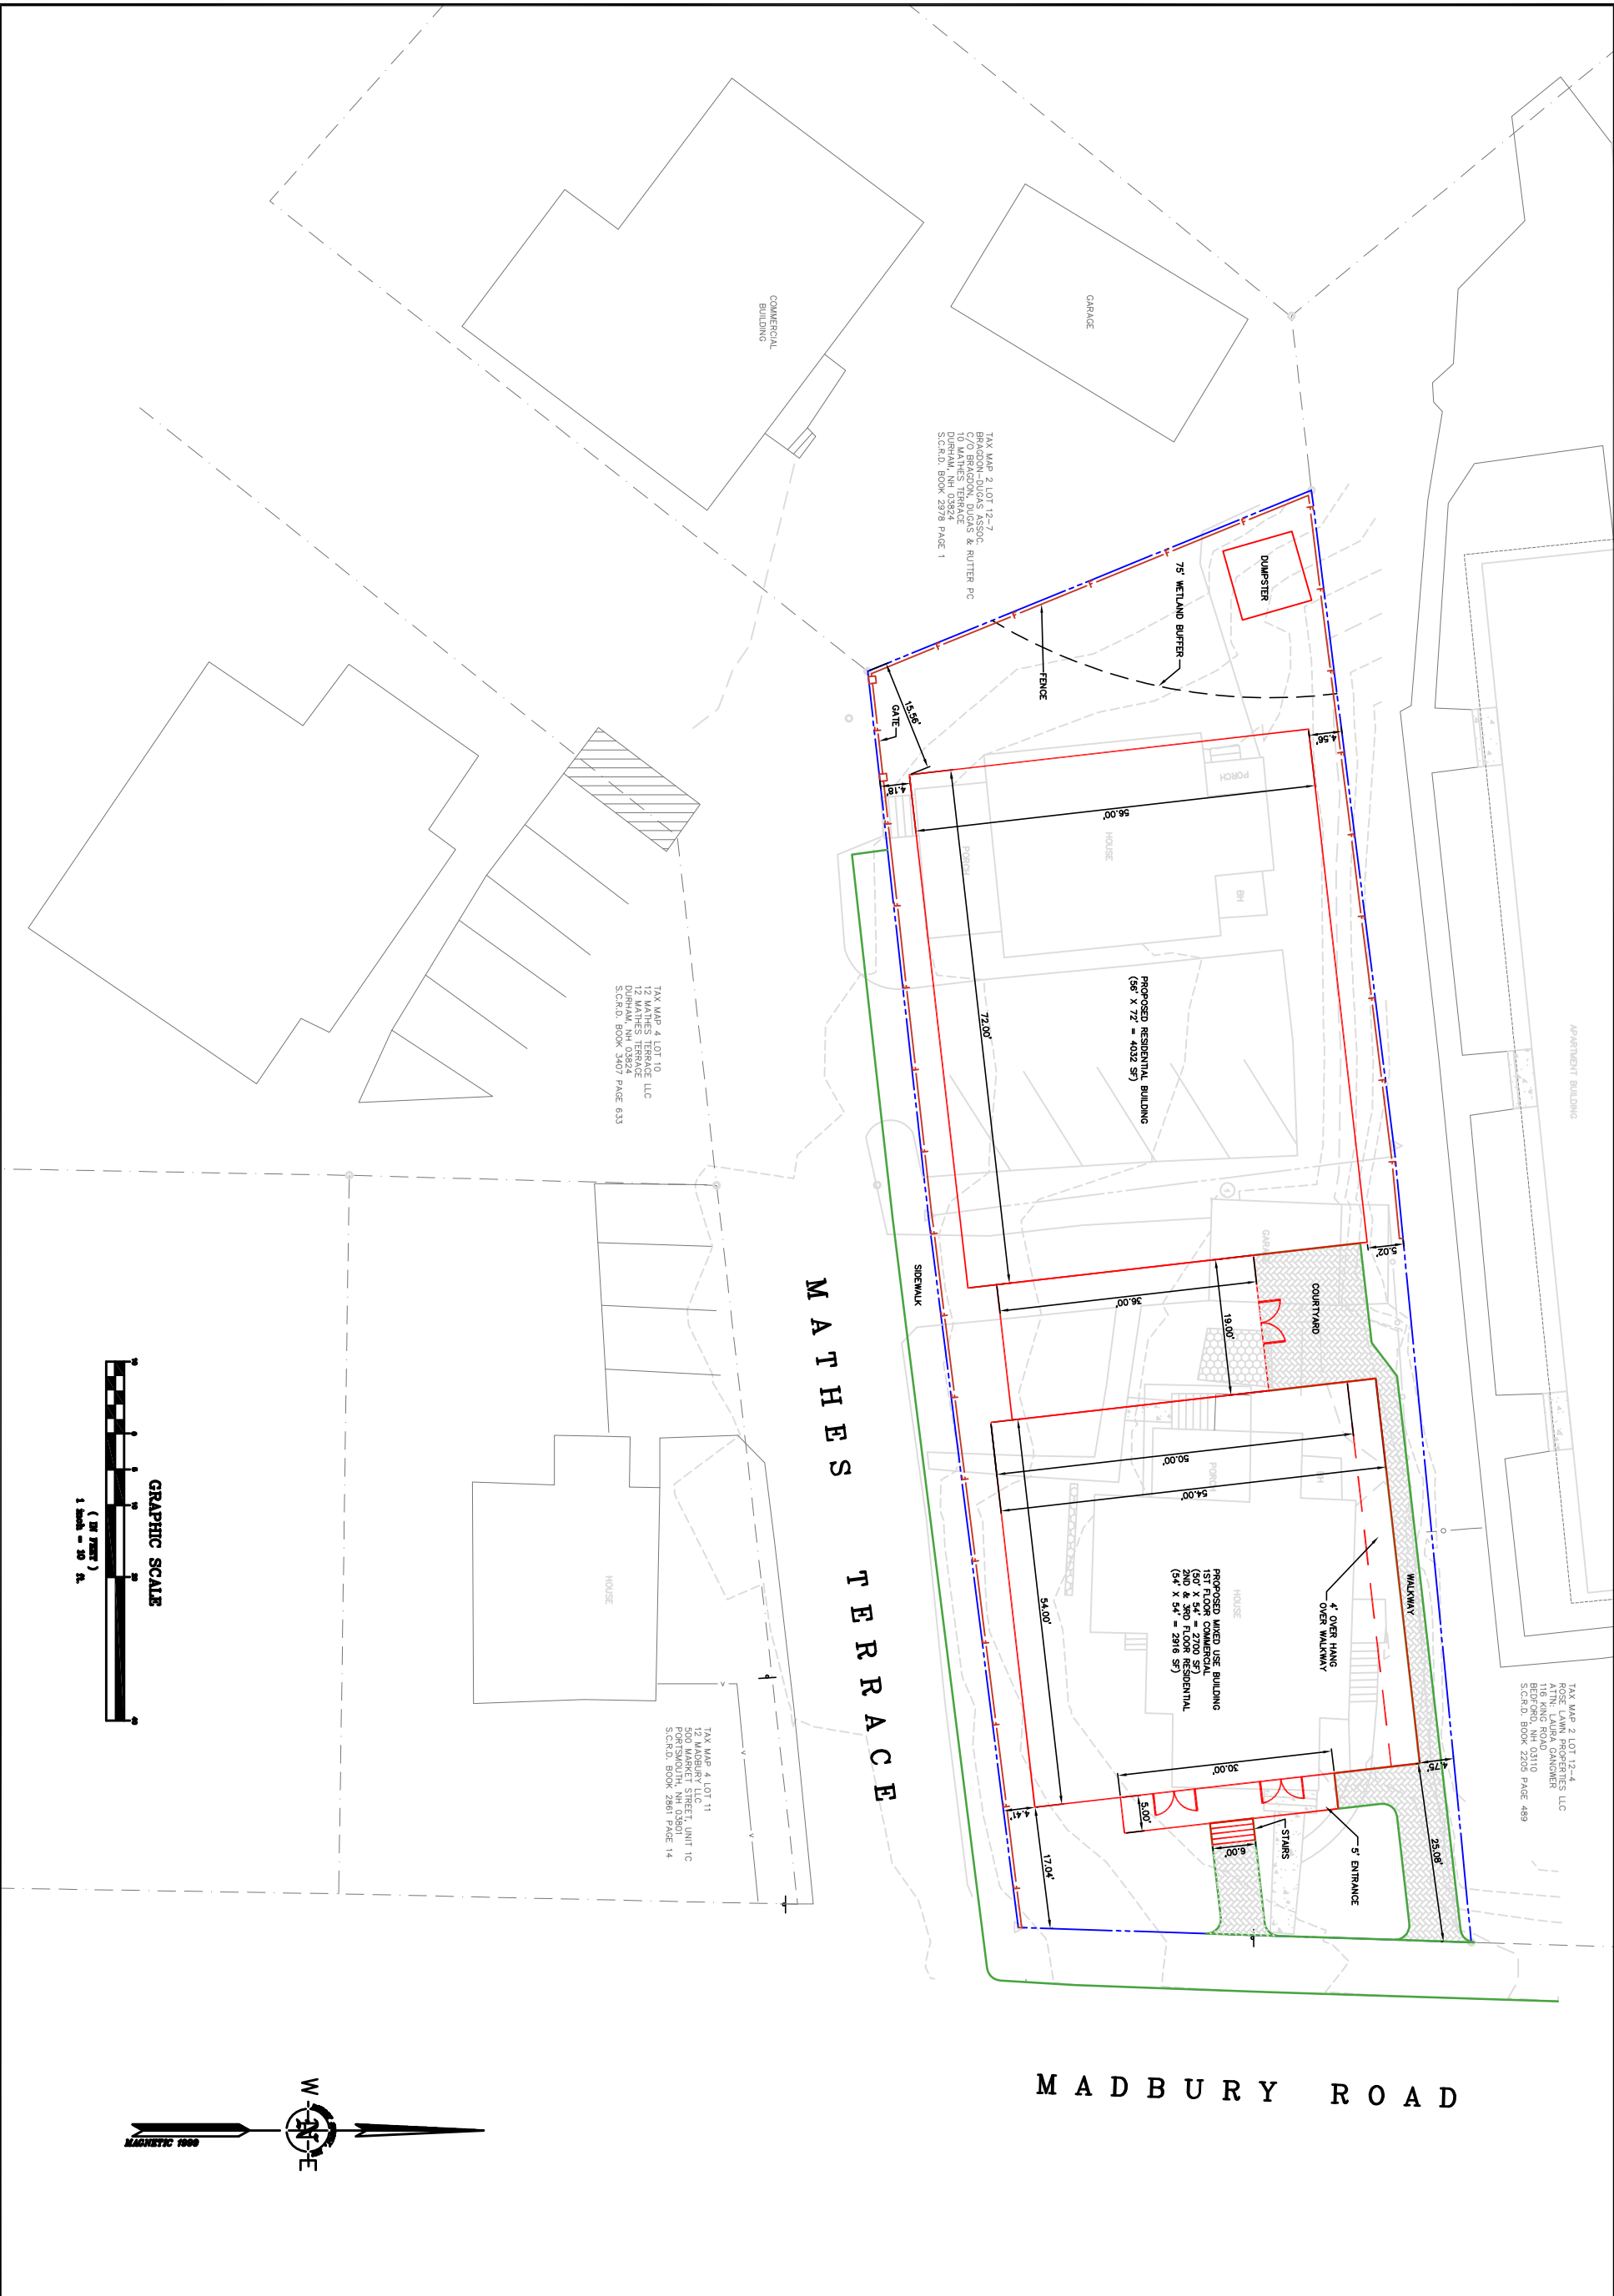

CP4	JOB: 13-023	MJS ENGINEERING, PC CIVIL ENVIRONMENTAL CONSULTING ENGINEERING 5 RAILROAD ST., P.O. BOX 359 DURHAM, NH 03824 PHONE: (603) 659-4979, FAX: (603) 659-4627 E-MAIL: HUS@MJS-ENGINEERING.COM	CONCEPTUAL SITE PLAN prepared for ISLAND DIVERSIFIED LLC (TAX MAP 2, LOT 12-5 & 12-6) MATHES TERRACE DURHAM, NH	DATE: 10/24/13 SCALE: 1"=10' DESIGNED BY: MJS/MS DRAWN BY: KD APPROVED BY: MJS DWG FILE:	SEAL				
						TO TOWN OF DURHAM			
						10/24/13 KD			
						DATE INT.			
						REVISIONS			
						NO.			